


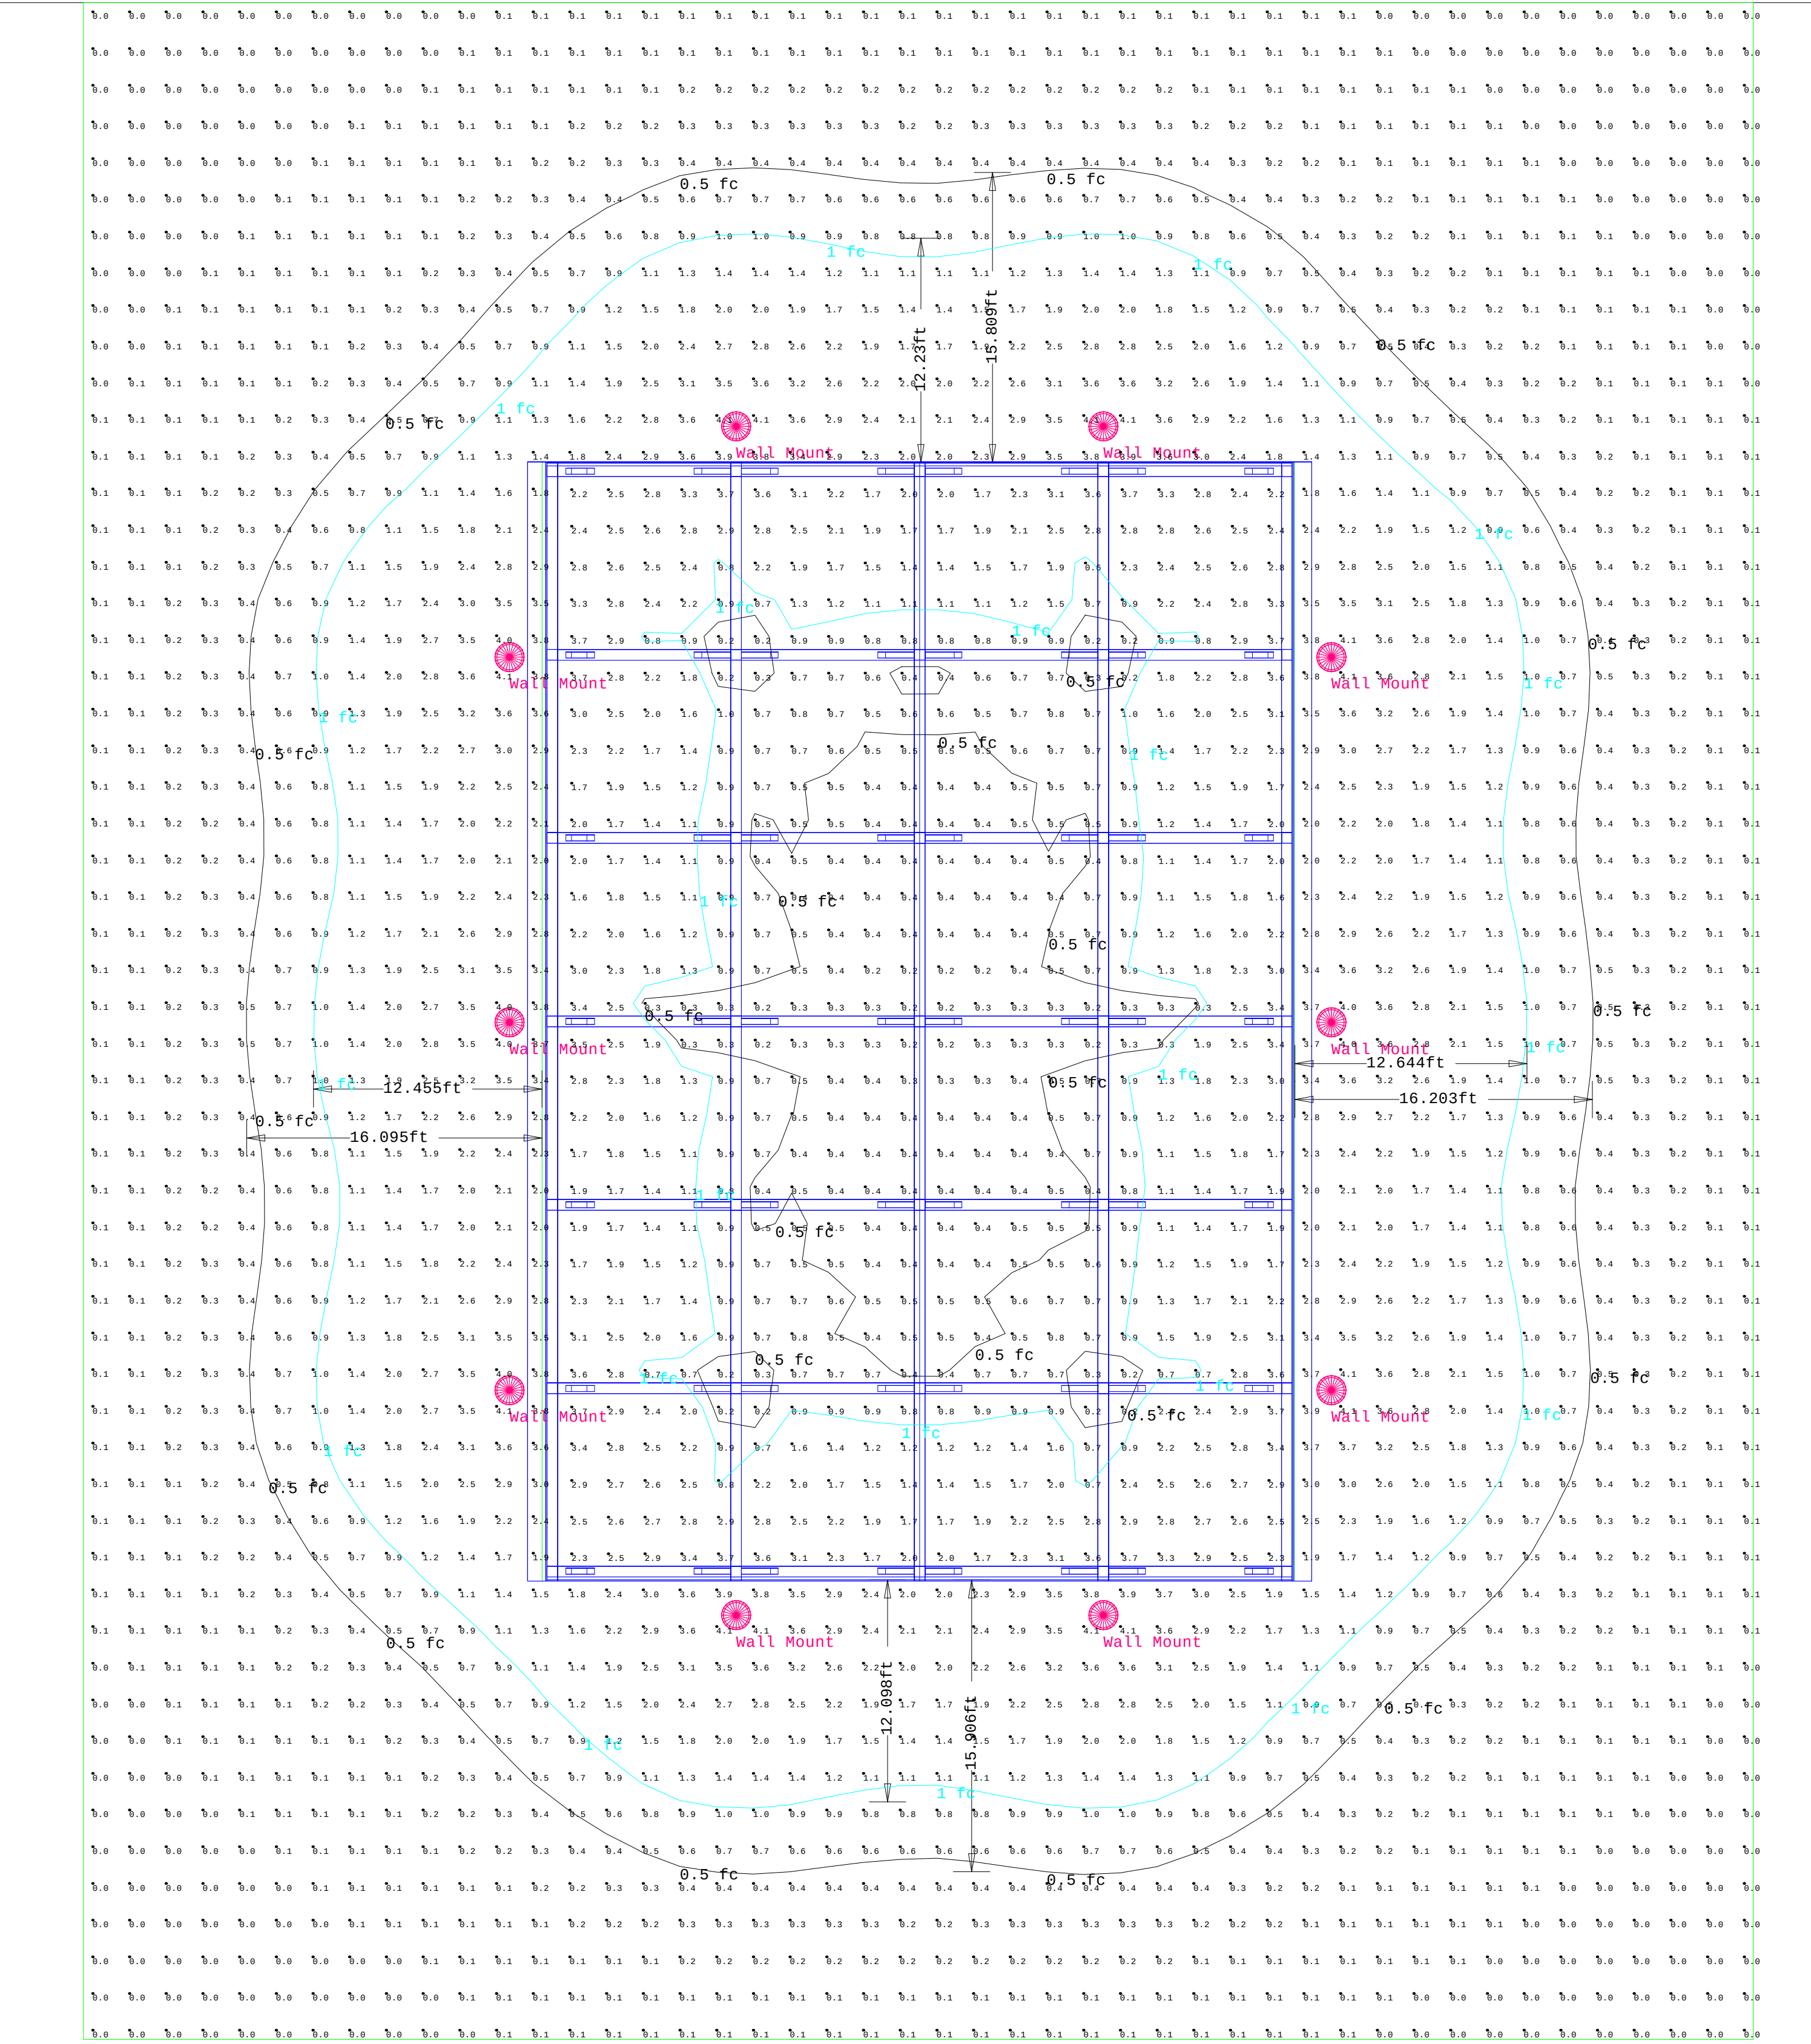

Luminaire Schedule					
Qty	Symbol	Label	Tag	Description	Lum. Lumens LLF
10		Wall Mount	Troy RLM	3RH18MBZP/3SL23BZP	1149 0.900

Calculation Summary						
Label	Units	Avg	Max	Min	Avg/Min	Max/Min
Exterior_Planar	Fc	0.87	4.1	0.0	N.A.	N.A.
Pavilion	Fc	1.38	3.7	0.2	6.90	18.50



Valley View Farm

Pavilion Calc

Drawn By: Nick Irwin

Checked By:

Date: 6/28/2016

Specifier:

Scale: NTS

Revisions

#	Date	Comments
X	XX/XX	XXXXXXXXXX